

GROUND FLOOR PLAN

PROJECT:

DESIGNER: ALPHA ENGINEERING CONSULTANT
ANAMNAGAR, KATHMANDU

TEL. PH. NO: 4288604

P.O. BOX NO: 10495

SHEET:
ARCHITECTURAL DRAWINGS

SCALE: 1"=8'-0"

DATE: JAN, 2016

DRAWN: NEELAM BYANJANKAR


DESIGN: RUBIN BISHMI

CHECKED: K.B. RANA

APPROVED:

SHT. NO:

1:01

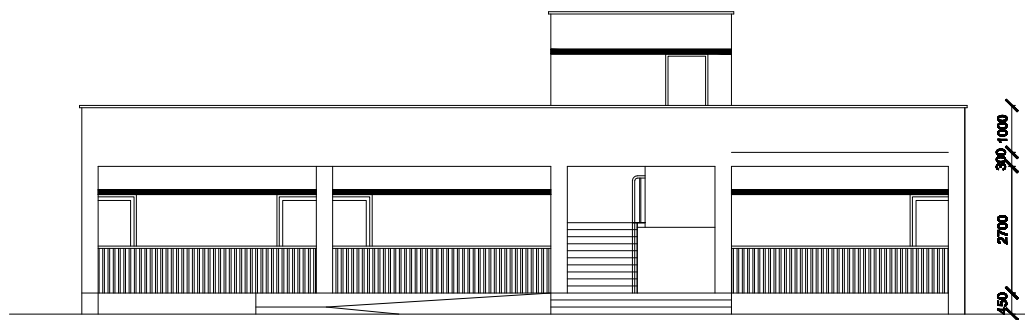

FRONT ELEVATION

PROJECT:

DESIGNER: ALPHA ENGINEERING CONSULTANT
ANAMNAGAR, KATHMANDU

TEL. PH. NO: 4268604

P.O. BOX NO: 10495

SHEET:

ARCHITECTURAL DRAWINGS

SCALE: 1"=5'-0"

DATE: JAN, 2016

DRAWN: NEELAM BYANJANKAR

DESIGN: NABIN BASNET

CHECKED:

APPROVED:

SHT. NO:

2:01